

1.1 DRAWINGS

- .1 Mechanical:
 - .1 Refer to attached Plumbing DWV sketch SKM-M02.
 - .2 Plumbing Fixture Schedule;
 - .1 Plumbing Fixture L-1 is not supplied by Owner as indicated. The sink is moulded into the countertop and supplied by the general contractor.
- .2 Electrical:
 - .1 Responses to questions posed during tender period;
 - .1 Communications for building: The Owner will select a service provider for internet/WIFI services, the electrical contractor will coordinate with service provider. Plywood backboard has been provided in the comm's room for service provider.
 - .2 New Pole: The new power pole will be paid for by the Owner, contractor shall coordinate with NSPC.
 - .3 Underground service: No, overhead as indicated.
 - .4 Electrical in block walls: Contractor shall recess boxes/conduit in new concrete block walls.
 - .5 Ceiling wiring: wiring in the ceiling space may be BX in lieu of conduit.

THIS DOCUMENT MUST BE SIGNED, SEALED AND SUBMITTED WITH YOUR TENDER.

Company Name (Printed): _____


AFFIX SEAL

Signature of Representative: _____

Name (Printed): _____

Title (Printed): _____

Date: _____

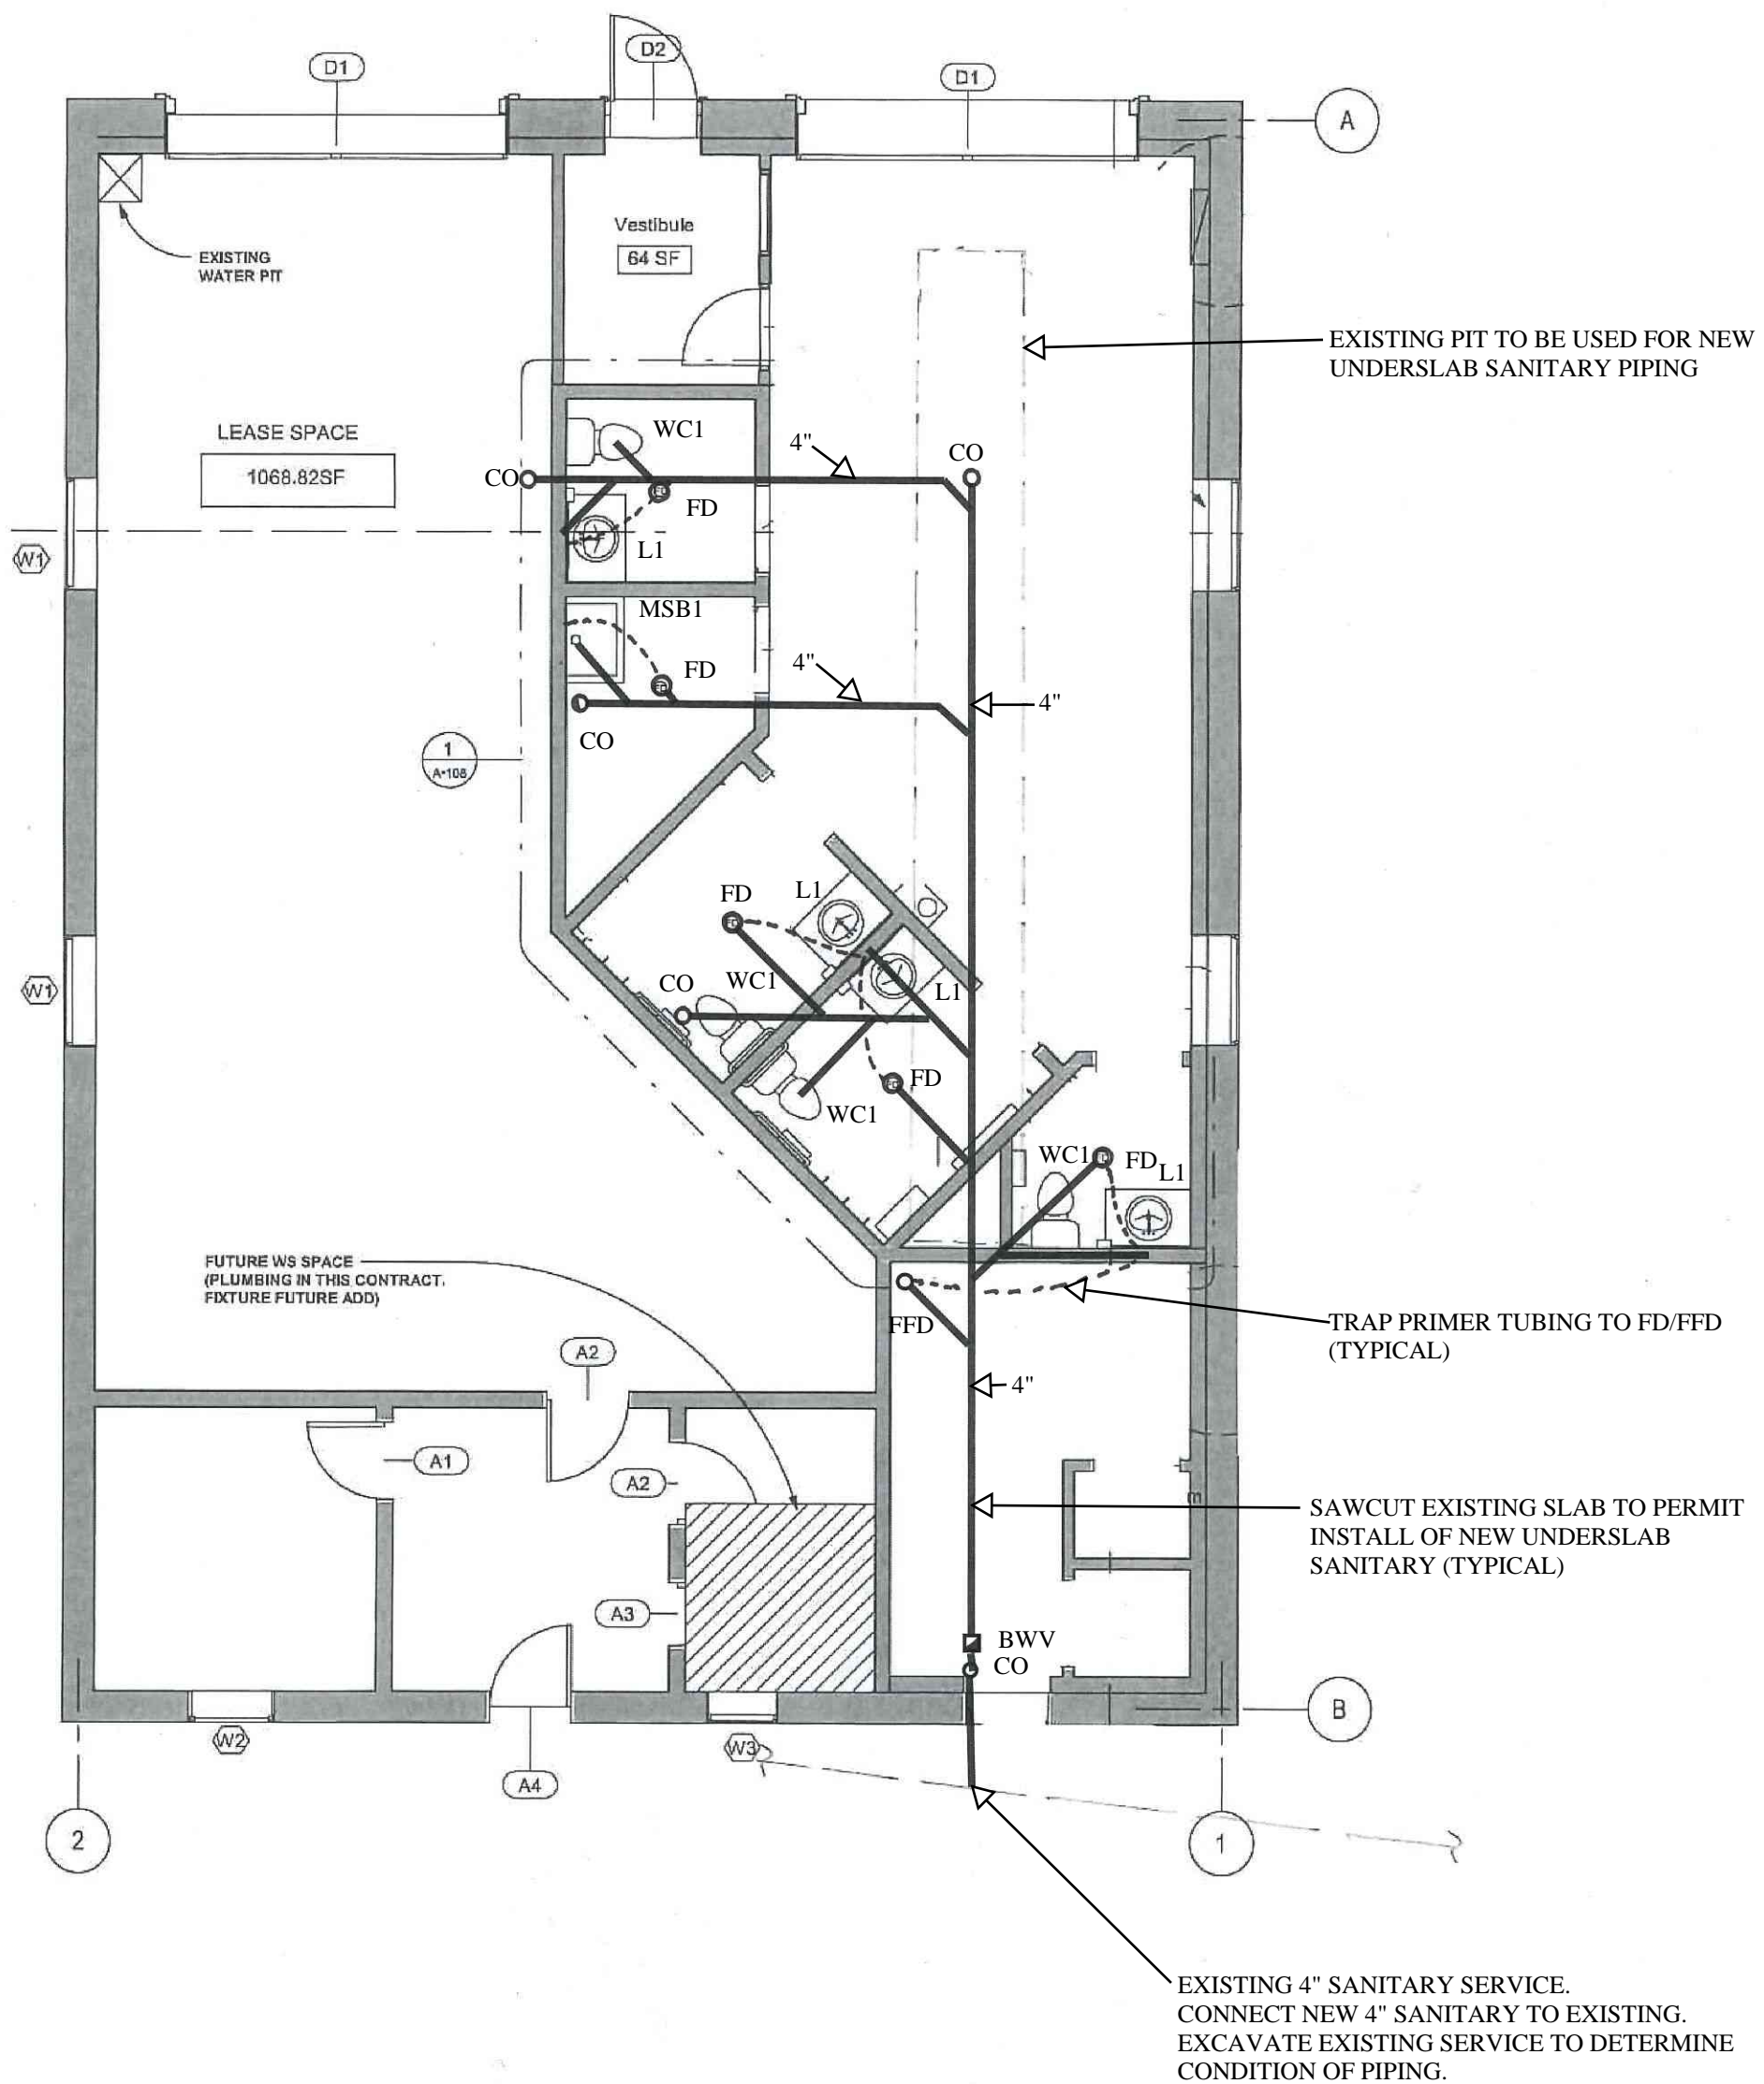

PLUMBING PLAN - DWV PIPING

SCALE: 1/4" = 1'-0"

SKM-M02